


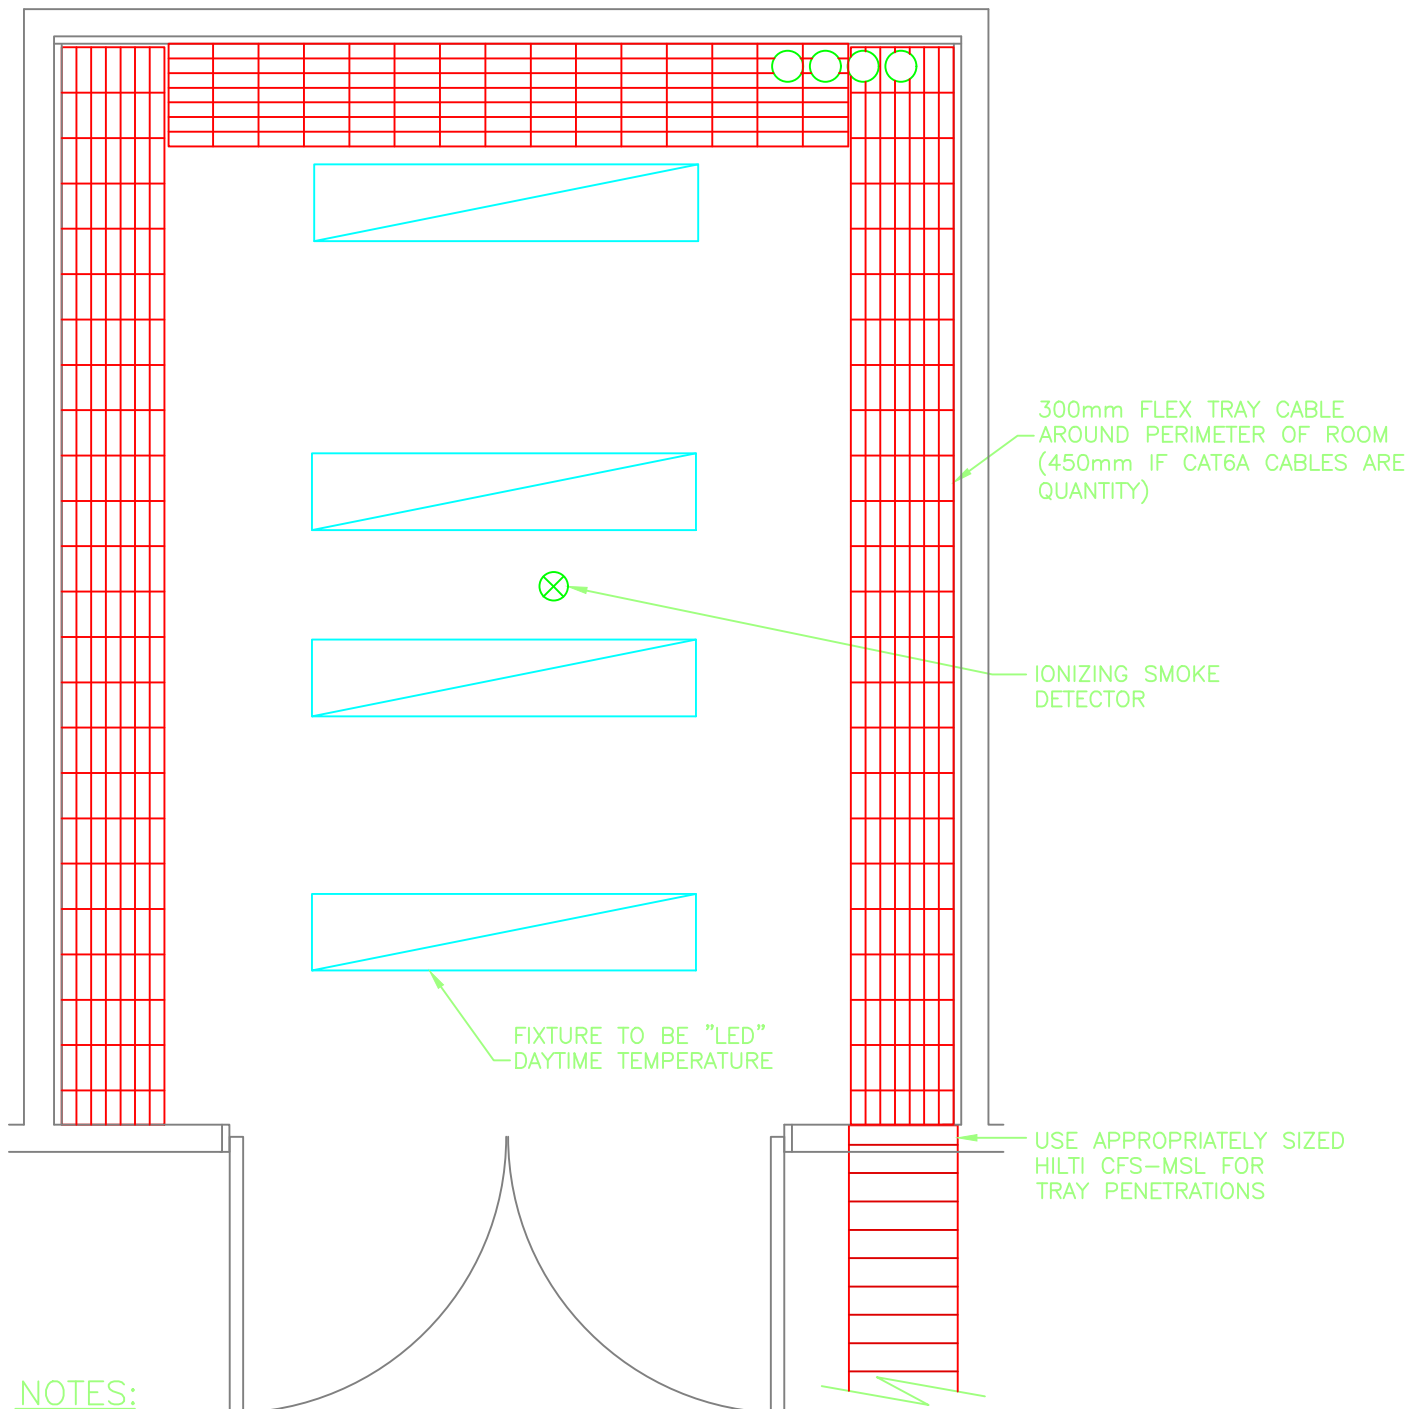

NOTES:

1. THIS DRAWING REPRESENTS A TYPICAL COMMUNICATIONS ROOM LAYOUT AND SHALL NOT BE TAKEN AS THE FINAL DESIGN.
2. THE ROOM SHALL NOT HAVE A FALSE CEILING
3. A SMOKE DETECTOR SHALL BE INSTALLED AT ALL TIMES. THE SPRINKLER HEAD, IF USED, SHALL BE A HIGH TEMPERATURE TYPE WITH A CAGE.
4. PROVIDE DRIP TRAYS FOR ALL FLUID CARRYING PIPING IN THE ROOM, ALSO FOR SPRINKLER HEAD INSTALLED ABOVE EQUIPMENT RACKS.

Sheet No.

1 of 1

	BY	DATE
Drawn	DE	JUN 2025
Checked		
Design'd	TZ	JUN 2025
Approved	EB	JUN 2025

MAIN COMMUNICATIONS ROOM REFLECTED CEILING PLAN (TYPICAL)

File No.

ITSTD-05

Rev.

1



THE UNIVERSITY OF BRITISH COLUMBIA
Information Technology